


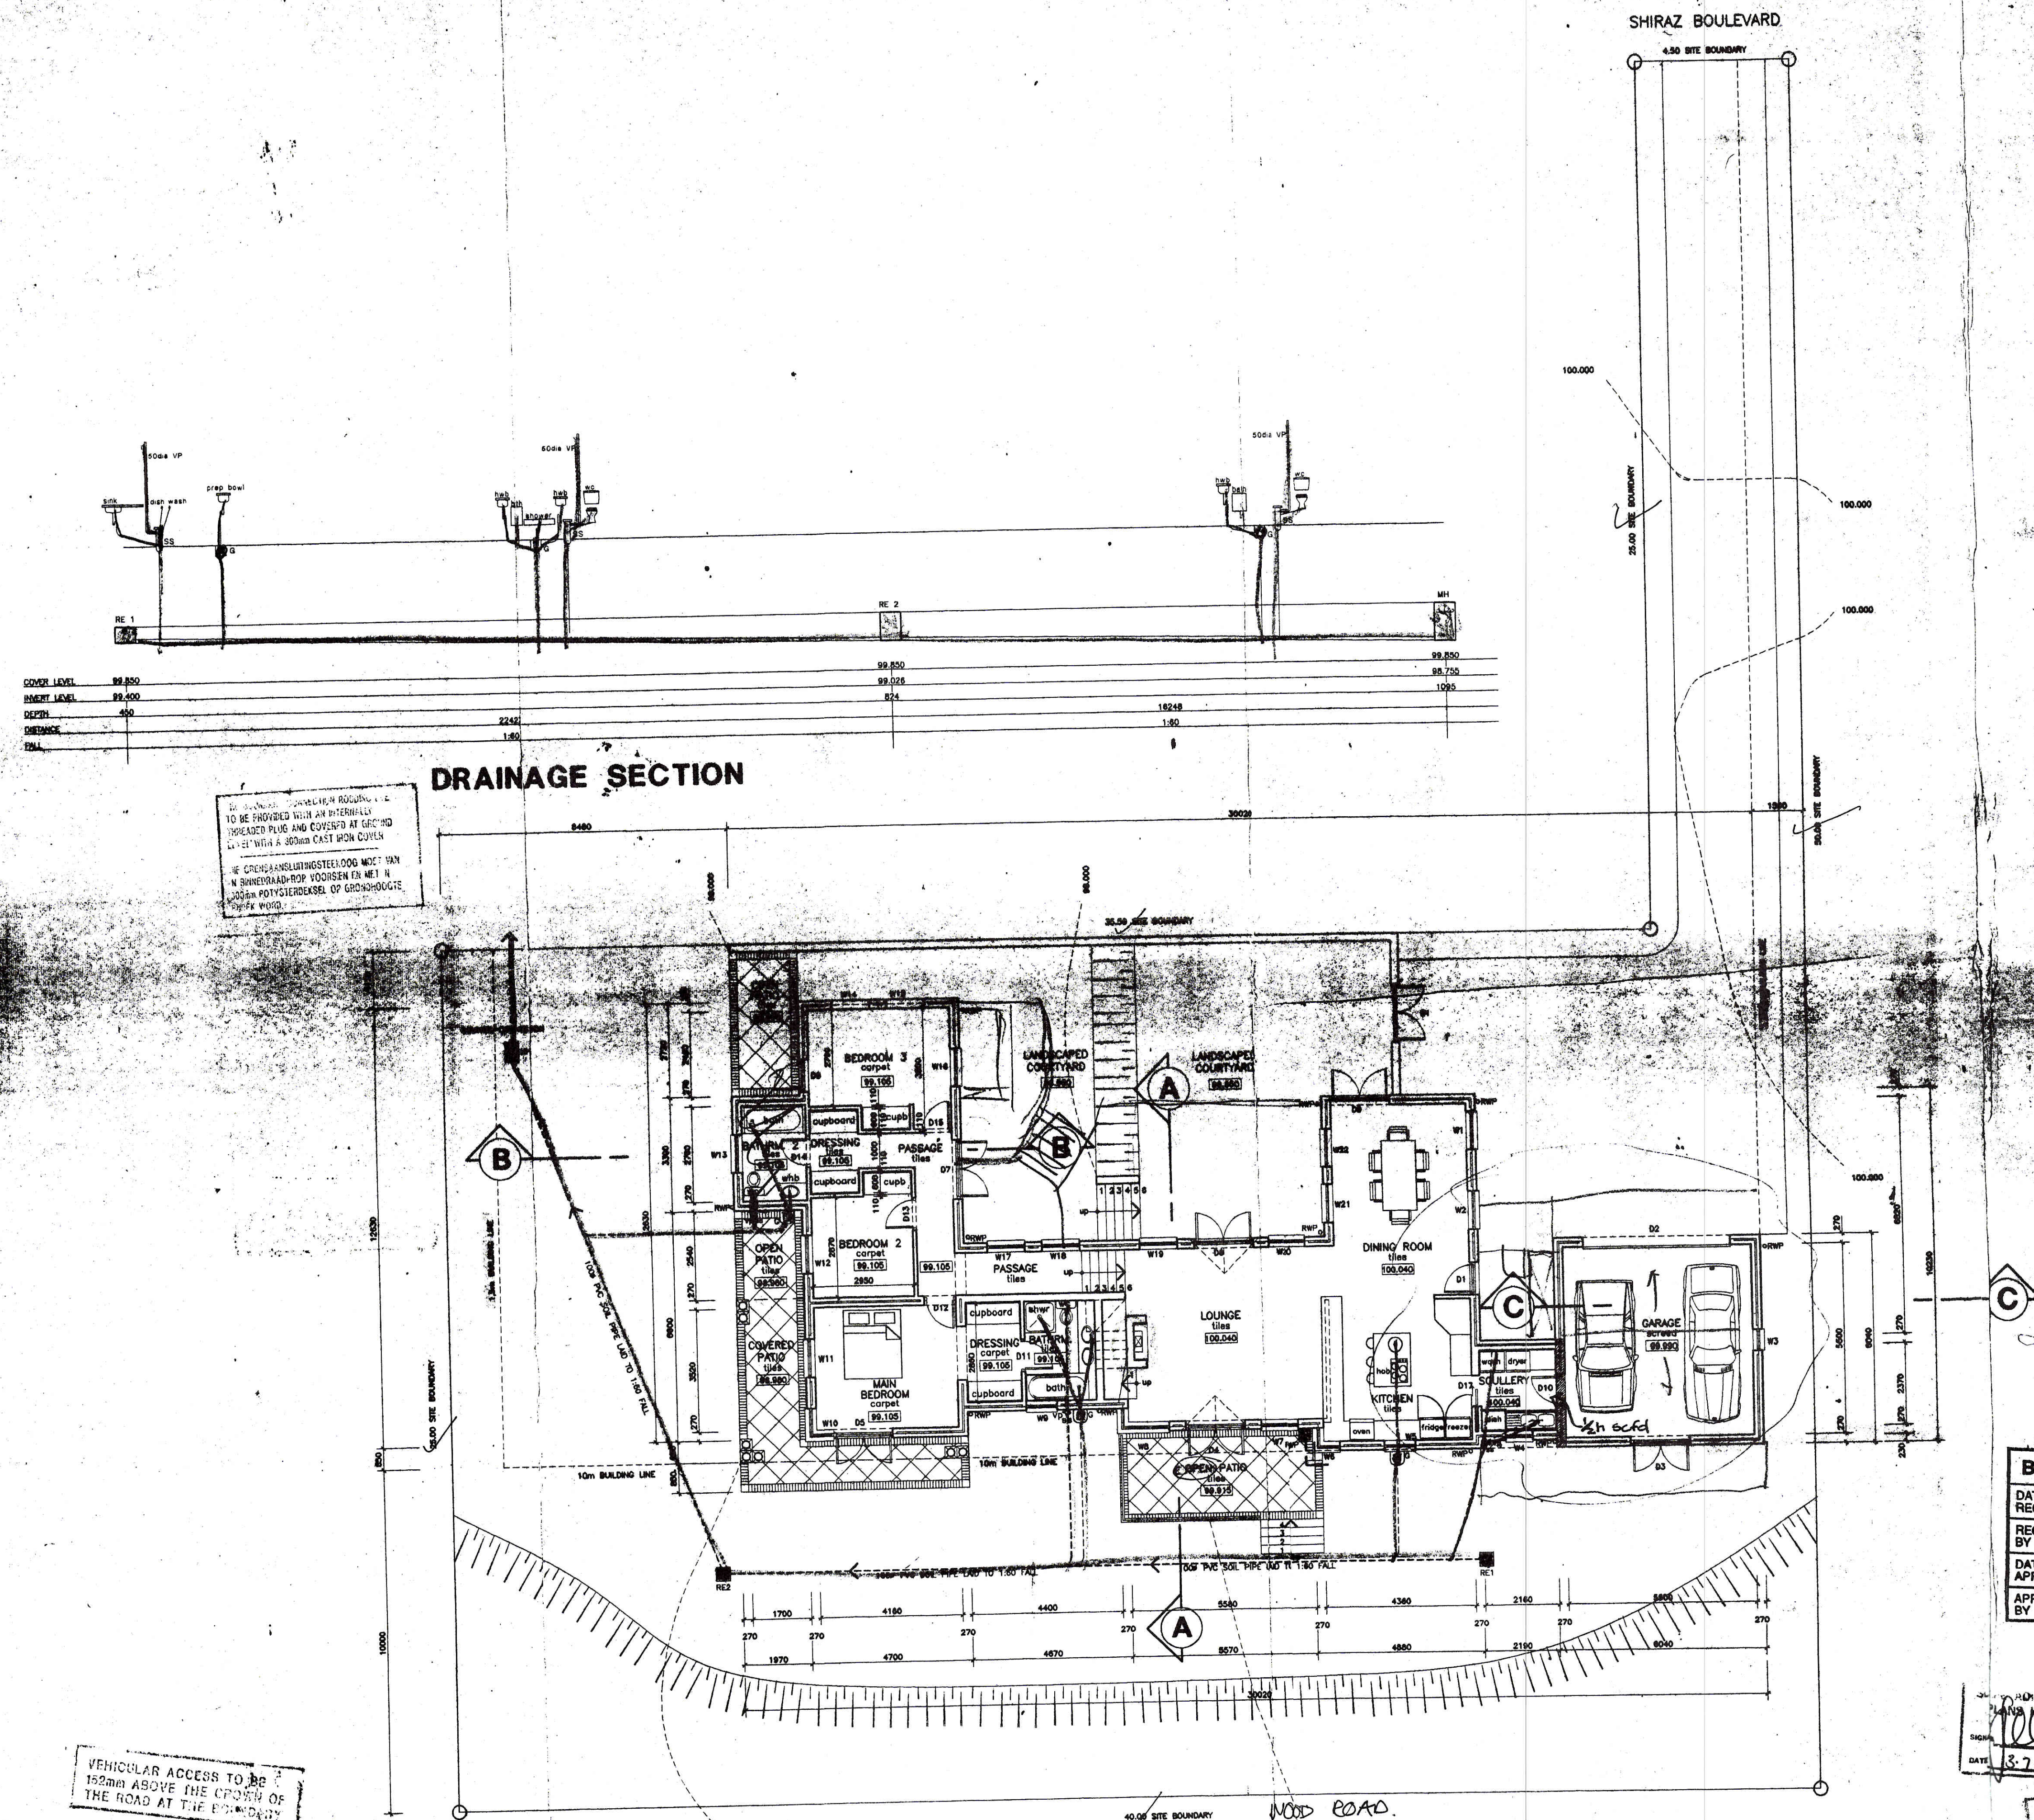

AREA CALCULATIONS

GROUND FLOOR = 174 sqm

FIRST FLOOR = 17 sqm

TOTAL = 191sqm

GARAGE = 37sqm

LEGEND:

 GARAGE WALL SHOWN HATCHED TO BE BEAMFILLED

Western Cape Regional Services Council
Western Cape Stock Exchanges Ltd

APPROVED/GOVERNMENT

Mr. Head of Cape Provincial Office
for Chief Executive of Stock Exchanges Services

DATE/TIME: - 6.7.1996

BY: Mr. [Signature] 129933

COUNCILS COPY

CLIENT _____		
ARCHITECT _____		
02	6/2/96	PATIO OVER MAIN BEDROOM MOVED ONTO BUILDING LINE, FIREPLACE MOVED
01	23/10/95	ALL LEAN-TO ROOFS AND COVERED BRAM AREA OMITTED
Rev. No.	Date	Description.

Notes:
Figured dimensions to be taken in preference to scaled dimensions.
Contractor to check all dimensions and levels before setting out any work.
All dimensions to be verified on site before commencing shop drawings.

BERG-EN-DAL		H O A
DATE RECEIVED		
RECEIVED BY		
DATE APPROVED	29/4/96	
APPROVED BY	<i>[Signature]</i>	

KLEIN ARCHITECTS & LOUW

CAPE TOWN: 81 ST JOHNS STREET
TEL: (021)457508 FAX: (021)4617980

Project	HOUSE CLOETE ERF 5802 BERG-EN-DAL
Client	MR & MRS CLOETE

Drawing GROUND FLOOR, SITE AND DRAINAGE LAYOUT	Date MAY 95
	Scale 1=100'

Project No.	Drawing No.	Revision 02
95-505	B-02	Drawn louise